

GENERAL NOTES:

- A PROJECT SITE IS ZONING TYPE NEIGHBORHOOD COMMERCIAL PER CHAPEL HILL ZONING MAP.
- B REFER TO SHEET ES002 FOR LIGHT FIXTURE CUTSHEETS.
- C MOUNTING HEIGHTS SHOWN ARE TO BOTTOM OF FIXTURE.
- D LIGHTING LEVELS SHOWN ARE MAINTAINED LIGHT LOSS FACTOR OF 0.9 WAS USED TO ACCOUNT FOR DIRT AND LUMEN DEPRECIATION.


KEY NOTES:

- 1 LIGHT TRESPASS OF SOUTHEAST PROPERTY LINE EXCEEDS INCREASE IN ILLUMINATION LIMIT OF 0.3 FOOTCANDLES. THE INCREASE IN ILLUMINATION IS FOR THE NEW PROPOSED WALKWAY AT THE INTERSECTION OF M.L.K., JR BLVD. AND LONGVIEW STREET.
- 2 LIGHT TRESPASS OF EAST PROPERTY LINE EXCEEDS INCREASE IN ILLUMINATION LIMIT OF 0.3 FOOTCANDLES. THE INCREASE IN ILLUMINATION IS FOR THE NEW PROPOSED WALKWAY AND PRIVATE DRIVE ALONG M.L.K., JR BLVD.

PHOTOMETRIC LIGHT FIXTURE SCHEDULE

TYPE	DESCRIPTION	VOLT	LAMPS		VA / FIXT.	MANUFACTURER	CATALOG NUMBER	B.U.G. RATING	NOTES	TYPE
			TYPE	QUANTITY						
B6	EXTERIOR RECESSED DOWNLIGHT, 2.5" ROUND APERTURE, 0-10V DIMMING, IP44 RATED FOR OUTDOOR CANOPIES	120V	LED, 500 LUMENS, 3000K, 90 CRI	5	5	LUMENWERX	LIGHT-LV2-SRR-TRM-FT-MES-SW-60DEG-30KSW-120V-05 HOUSING-LV2-SRR-TRM-SW-CASE	N/A	2	B6
P1	EXTERIOR LIGHT POLE AND POST TOP LED AREA LUMINAIRE, DIE-CAST ALUMINUM HOUSING, ACRYLIC LENS, 4" STRAIGHT ROUND STEEL POLE WITH BASE COVER, FIXTURE AND POLE TO BE BLACK FINISH, TYPE 4F DISTRIBUTION, 20FT POLE, WIRELESS MOTION SENSOR AND PHOTO SENSOR CONTROLS	UNV	LED, 7100 LUMENS, 3000K, 80 CRI	55	55	LSI	OPS-PT-8L-4F-LNV-30K3-ELK-ALBMR1	B2-U0-G1	1	P1
P2	EXTERIOR LIGHT POLE AND POST TOP LED AREA LUMINAIRE, DIE-CAST ALUMINUM HOUSING, ACRYLIC LENS, 4" STRAIGHT ROUND STEEL POLE WITH BASE COVER, FIXTURE AND POLE TO BE BLACK FINISH, TYPE 4F DISTRIBUTION, 19FT POLE, WIRELESS MOTION SENSOR AND PHOTO SENSOR CONTROLS	UNV	LED, 5300 LUMENS, 3000K, 80 CRI	41	41	LSI	OPS-PT-6L-4F-30K3-UD-EHS	B1-U0-G1	1	P2
S1	EXTERIOR ILLUMINATED BOLLARD, 3.5" DIA DIAMETER, ALUMINUM HOUSING, 0.7" ACRYLIC LENS, 0-10V DIMMING	UNV	LED, 1500 LUMENS, 3000K, 80 CRI	34	34	LUMENPULSE	ELM10-RO-277-30K-CRI-8A-S120-0-BK-ND	B0-U0-G1		S1
S2	EXTERIOR ILLUMINATED BOLLARD, 4.75" DIA DIAMETER, ALUMINUM HOUSING, 0.7" ACRYLIC LENS	UNV	LED, 800 LUMENS, 3000K, 80 CRI	24	24	LUMENPULSE	ELM10-RO-277-30K-CRI-8A-S120-0-BK-ND	B0-U0-G1		S2
W1	EXTERIOR RECTANGULAR AREA LIGHT, WALL MOUNTED, 24" W x 9" H x 2.5" D ALUMINUM HOUSING IN BLACK FINISH, WET LOCATION LISTED, 0-10V DIMMING	UNV	LED, 3000 LUMENS, 3000K, 80 CRI	32	32	BROWNLEE	7075-24-9H-32-30K	B1-U0-G1		W1
W2	EXTERIOR RECTANGULAR AREA LIGHT, WALL MOUNTED, DIRECT ONLY LIGHT DIRECTION, WIDE FLOOD BEAM ANGLE, WET LOCATION LISTED	UNV	LED, 450 LUMENS, 3000K, 80 CRI	7	7	DELTA LIGHT	N7A-DN-45-27-27-SP-WVFL-6-PS-INC-08-120	B0-U0-G0		W2

Location	CalcType	Units	Avg	Max	Min	HighMin	MaxMin	Grid
DRIVEWAY - EAST	Burnance	Fc	2.79	4.7	0.0	N/A	N/A	N/A
PARKING ENTRY	Burnance	Fc	2.77	8.8	0.0	10.85	4.55	0
PROPERTY LINE - EAST	Burnance	Fc	1.98	6.1	0.0	N/A	N/A	N/A
PROPERTY LINE - SOUTH/EAST	Burnance	Fc	5.13	0.7	0.0	N/A	N/A	N/A
PROPERTY LINE - WEST	Burnance	Fc	0.00	0.0	0.0	N/A	N/A	N/A
PROPERTY LINE - SOUTH/WEST	Burnance	Fc	5.00	0.0	0.0	N/A	N/A	N/A
SITE AGENCY - DOOR/REAR	Burnance	Fc	4.88	15.8	2.2	17.0	7.8	0
WALKWAY - EAST	Burnance	Fc	3.48	8.0	1.0	13.4	6.00	N/A
WALKWAY - SOUTH	Burnance	Fc	5.93	0.3	0.0	N/A	N/A	N/A

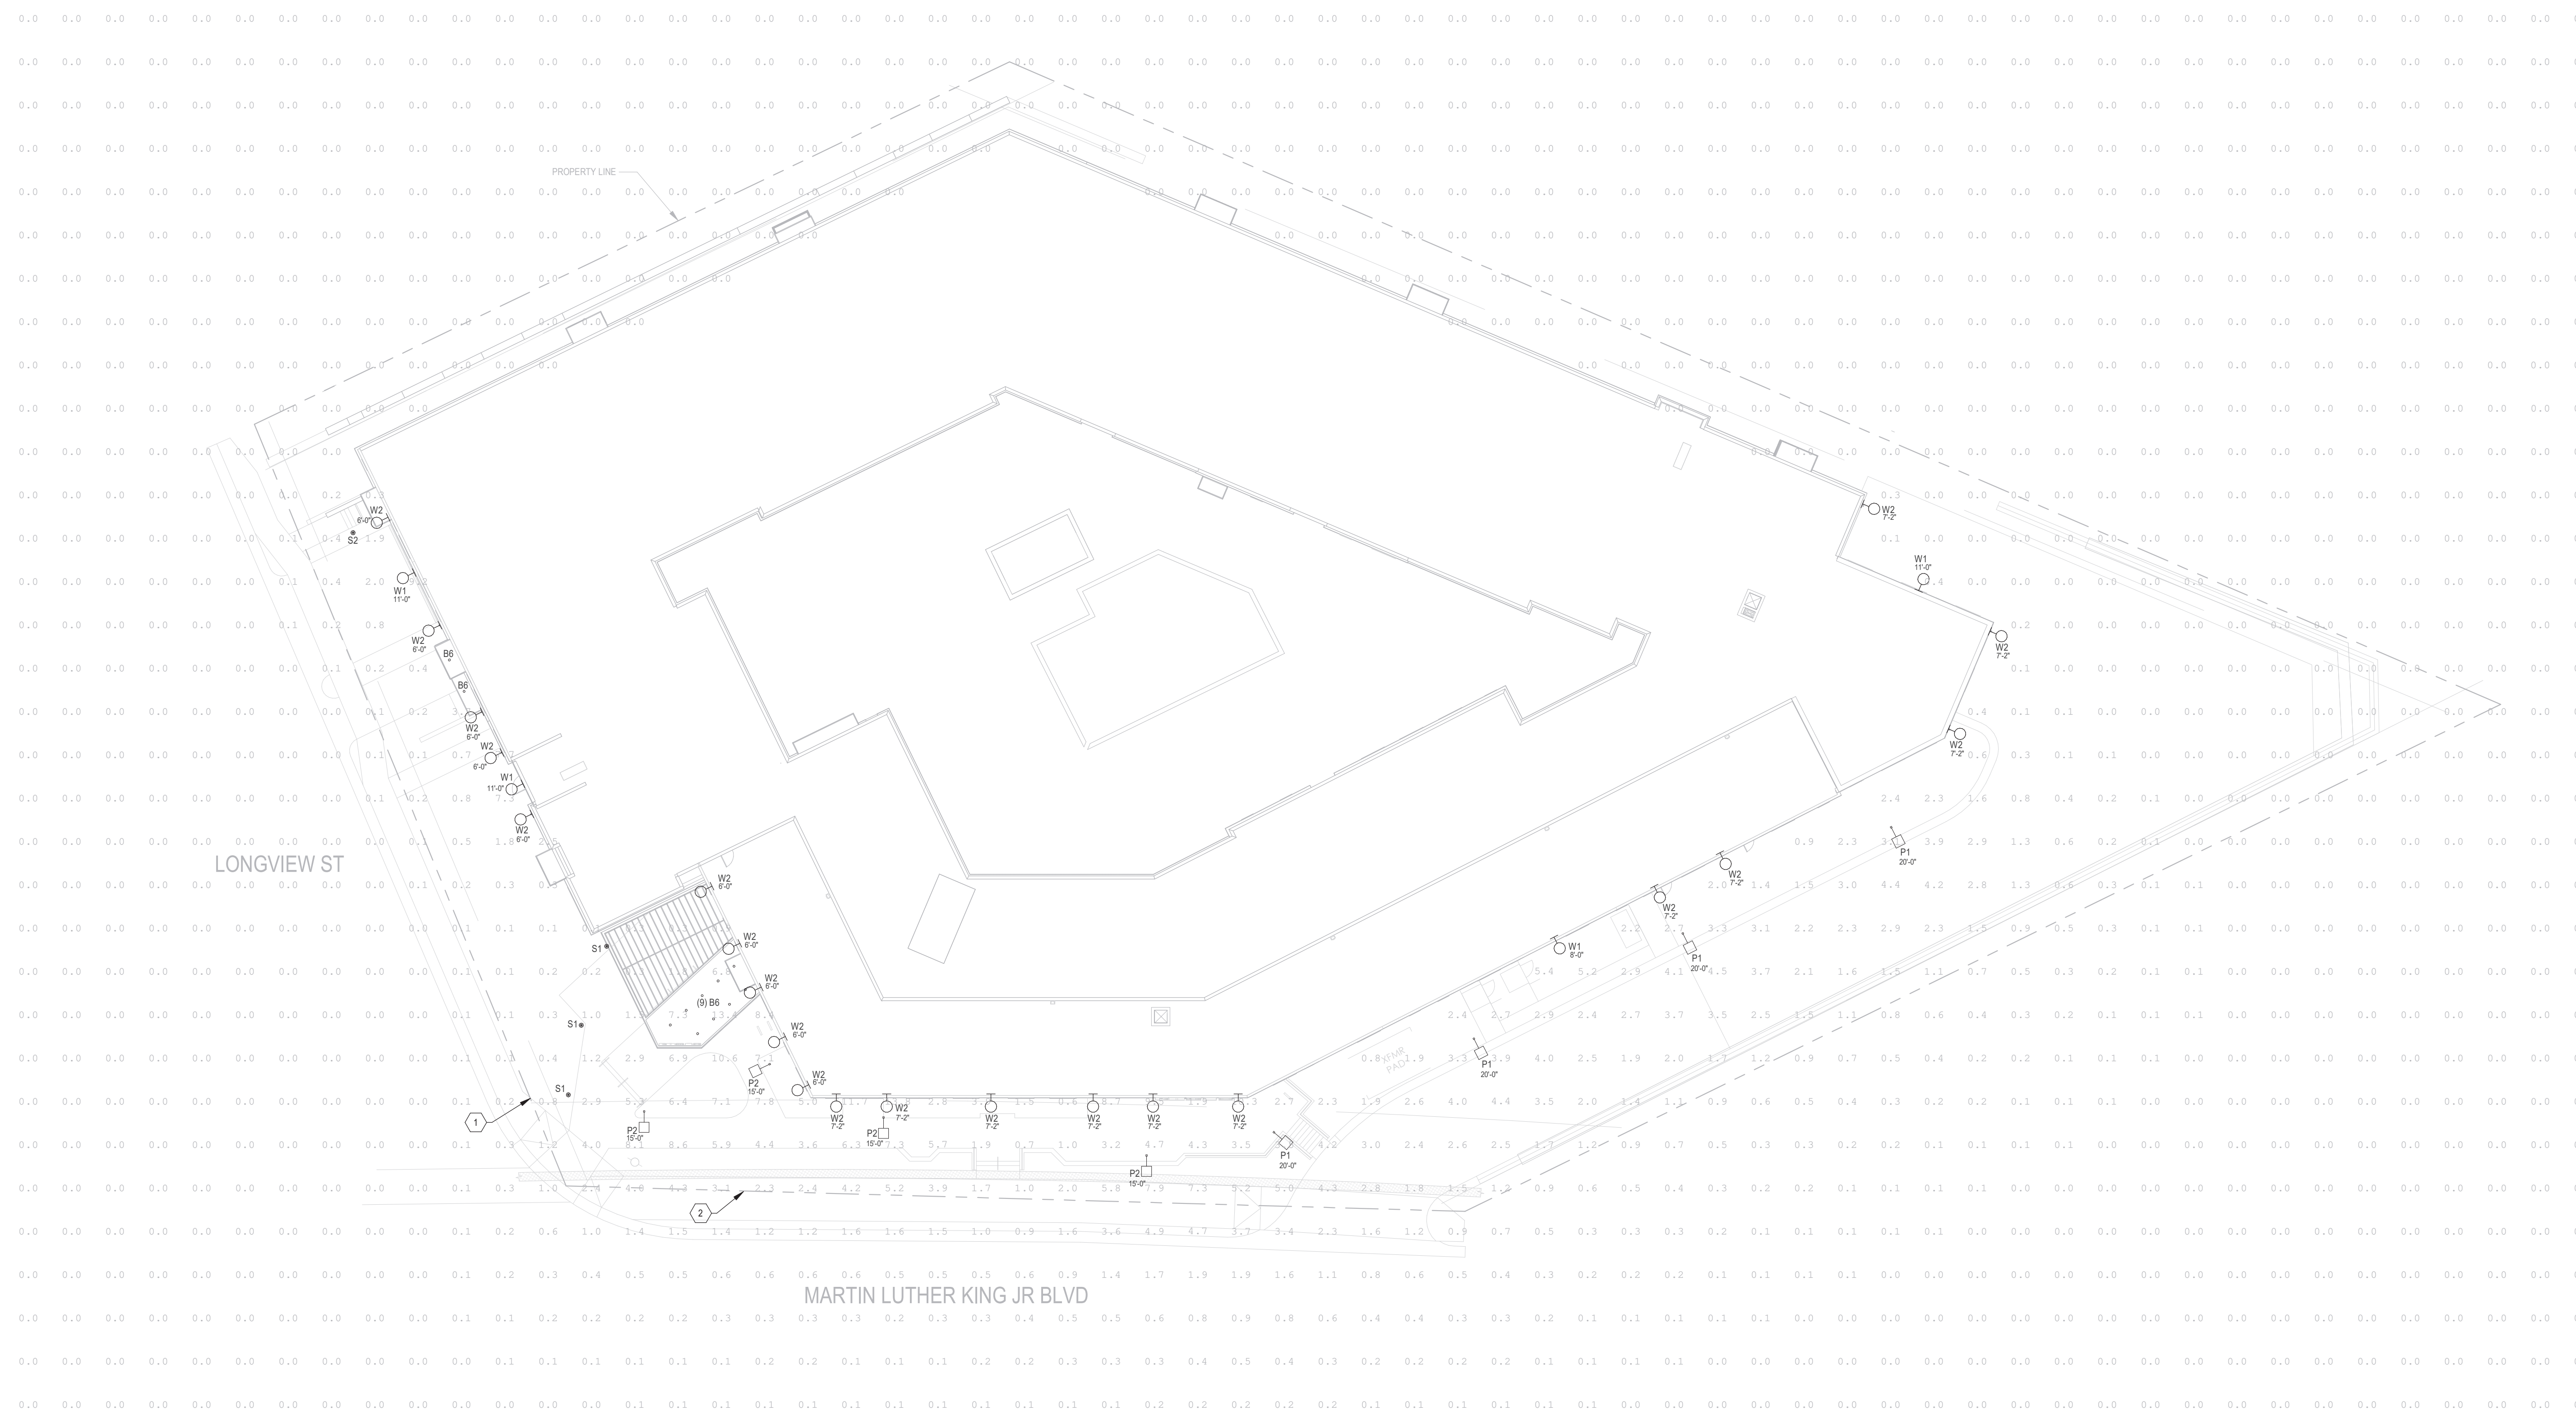

1 SITE PHOTOMETRIC PLAN
SCALE: 1" = 20'-0"


NOT FOR CONSTRUCTION

100% DD

PROJECT: 5295.0000
DATE: 03.24.2026
REVISIONS: DATE

*P# = PERMIT, R# = RFI, # = REVISION
DRAWN BY: Author
CHECKED BY: Checker
SITE PHOTOMETRIC PLAN

Opulence Post Top (Zero Uplight) Outdoor Decorative Post Top



OVERVIEW

Light Production (lm)	11000 - 17000
Wattage Range (W)	20 - 105
Efficiency Range (L/W)	184 - 160
Mounting Ht. (ft)	25 (11.3)

FEATURES & SPECIFICATIONS

Construction

- Finished cast aluminum housing
- Finished and finished with LSA's Duragrip[®] polyester powder coat finishing process. The Duragrip finish withstands extreme weather changes without cracking or peeling. Other standard LSA finishes available. Contact factory.

Optical System

- High density LED optical system delivers industry leading optical performance and visual comfort.
- Dispersion beam 2, 3W, 4W, 5W, 8W, 10W, 15W, 20W, 8720W, 8725W