


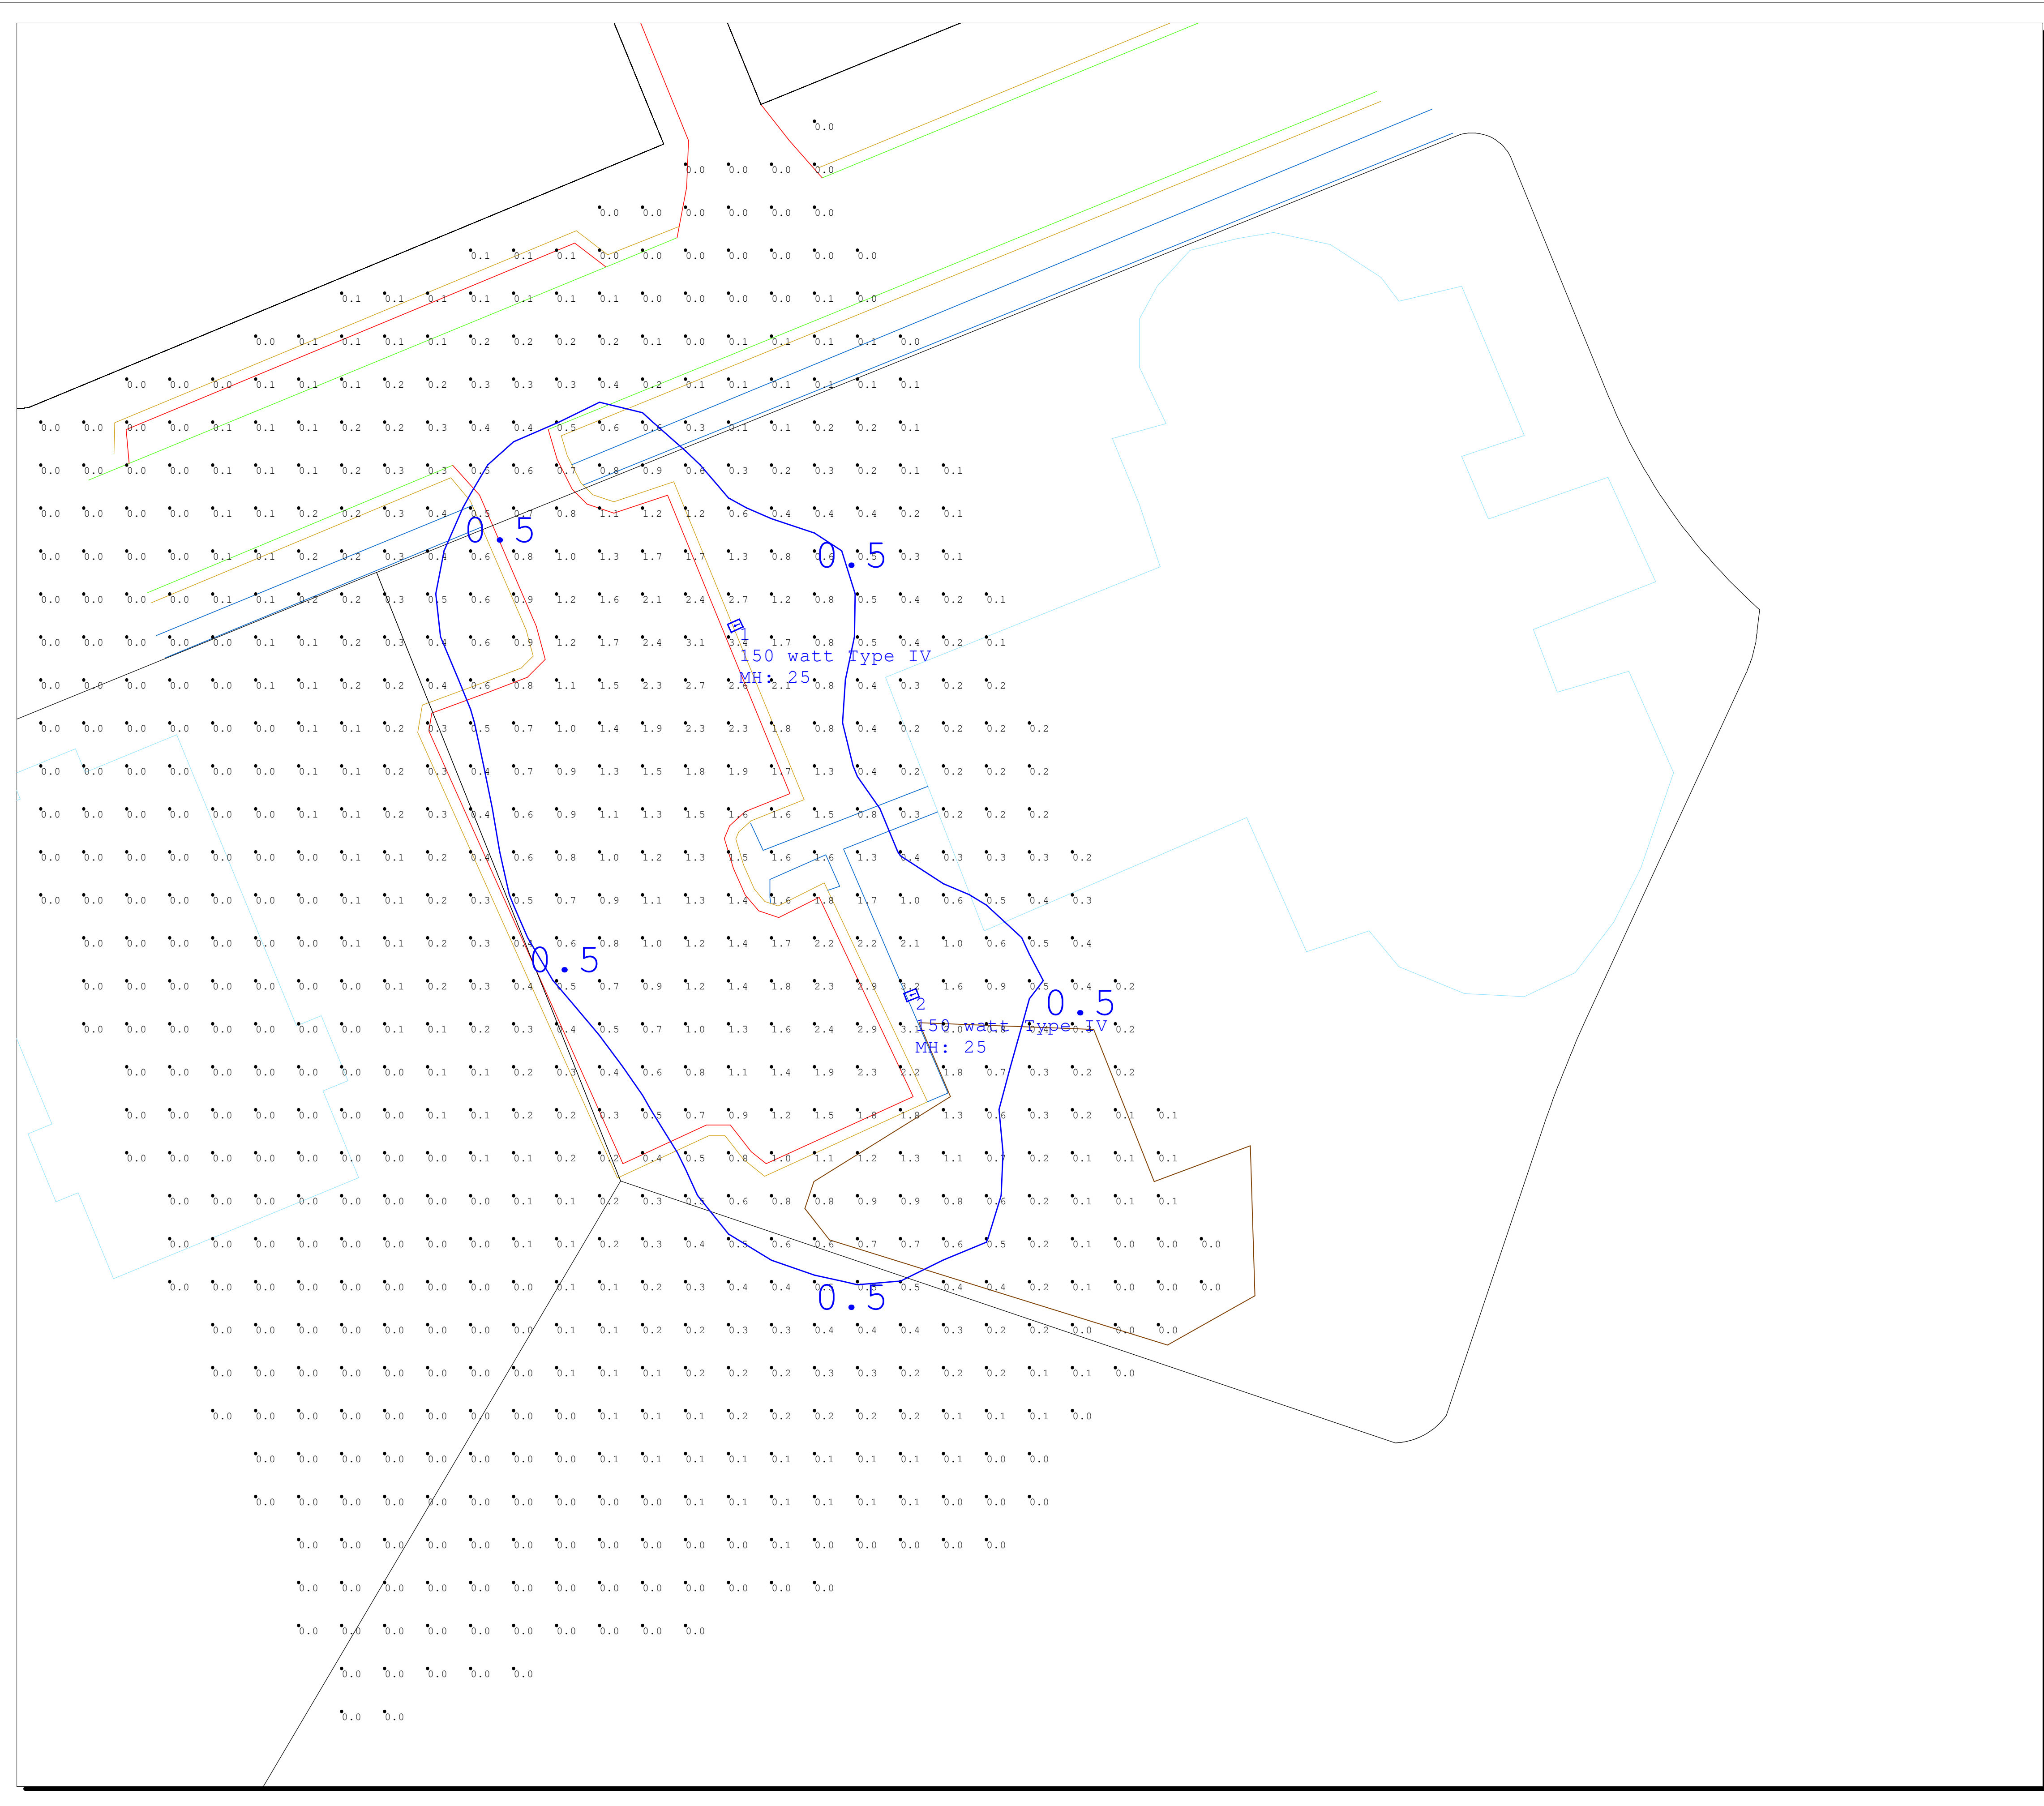


Luminaire Schedule					
Symbol	Qty	Label	Arrangement	Total Lamp Lumens LLF	
[Symbol]	2	150 watt Type IV	SINGLE	N.A.	0.850
Calculation Summary					
Label	CalcType	Units	Avg	Max	Min
site	Illuminance	Fc	0.37	3.4	0.0
Luminaire Location Summary					
LumNo	Label	Mounting	Height	Orient	
1	150 watt Type IV	25		204.444	
2	150 watt Type IV	25		201.371	

POLE STYLE A



Description:
Pole Style A is a round, smooth tapered shaft available in varying heights, anchor based or direct buried
Colors: Bronze, Black, Gray, Green (not available in all mounting heights)
Material: Fiberglass
Mounting heights:
Anchor Based Flush Mount: 12ft
Anchor Based with Concrete reveal: 25ft, 30ft, 35ft
Direct Buried: 12ft, 15ft, 20ft, 25ft, 30ft, 35ft

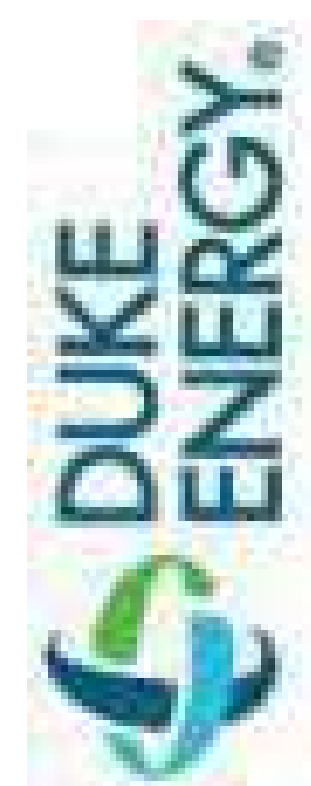

#	Date	Comments
Revisions		

Drawn By: Tom Grantham, LC, CEM
Checked By:
Date: 4/29/2021
Scale: 1"=20'

800 MARKET ST
Chapel Hill